


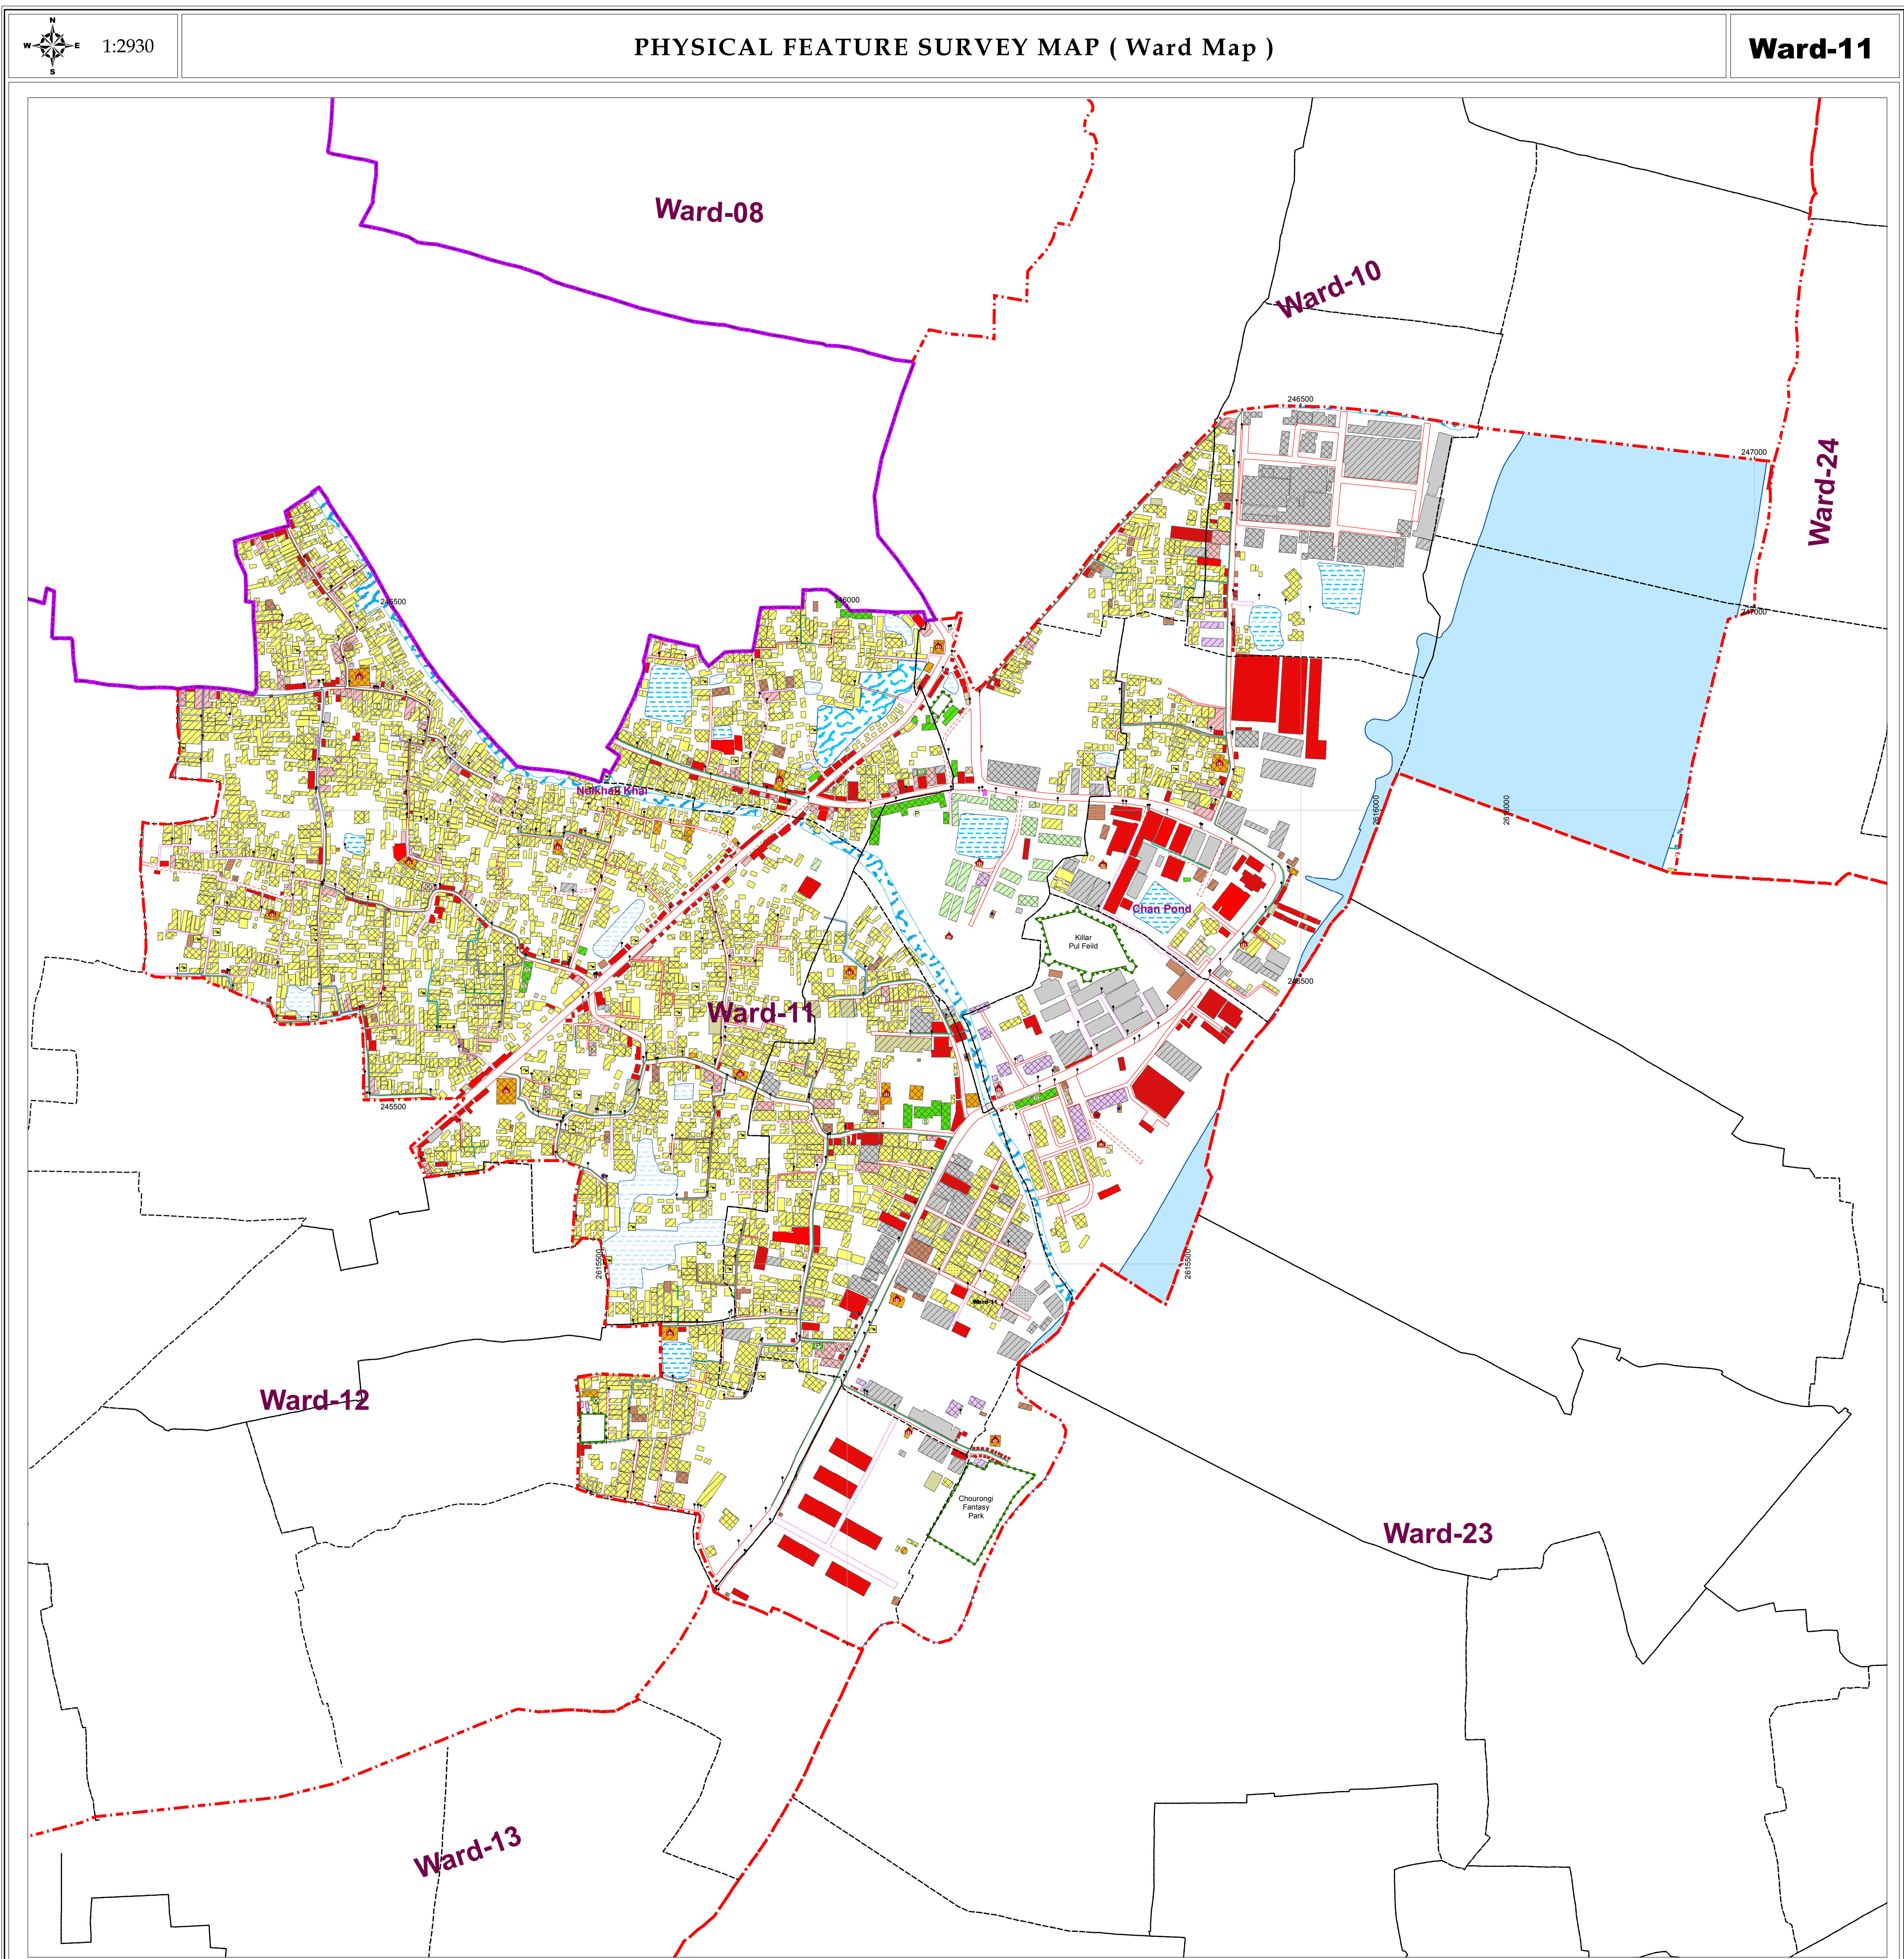

CONSULTANT

Development Design Consultants Ltd.
47 Mohakhali C/A, Dhaka 1212, Bangladesh

PREPARATION OF ACTION AREA PLAN FOR NARAYANGANJ CITY CORPORATION

230 207 184 161 138 115 92 69 46 23 0 230 460 690 Meters

730 657 584 511 438 365 292 219 146 73 0 730 1,460 2,190 Feet

Scale 1:990 or 1cm = 25.15 m or 1" = 82.5 ft

Government of the People's Republic of Bangladesh
Ministry of Local Government, Rural Development and Cooperatives
Local Government Division

Local Government Engineering Department (LGED)
Preparation of Action Area Plan Narayanganj City Corporation (NCC)

Administrative Index BANGLADESH

Administrative Index NARAYANGANJ DISTRICT

Administrative Index NARAYANGANJ CITY CORPORATION

LEGEND

City Corporation Boundary

Ward Boundary

Mauza Sheet Boundary

Mauza Plot Boundary

1:990 Grid Boundary

Divisional Headquarter

Zila Parishad Office

City Corporation Office

District Headquarter (DC Office)

Upazila Headquarter

Union Parishad Office (Defunct)

Road (Pucca)

Road (Semi-pucca)

Road (Katcha)

Footpath

Road Island

Drain (Pucca)

Drain (Katcha)

Railway

Embankment

Right of Way

High Volt Electric Line

Boundary Wall

Water Supply Line

Dustbin

Electric Pole

Electric Transformer

Light Post

Garbage Disposal Site

Monument/ Shahid Minar

Bus Terminal

Truck Terminal

High-Volt Electric Tower

Mobile Tower

TV/Radio Tower

Telephone Tower

Wireless Tower

Traffic Signal Post

Telephone Box

Telephone Pole

Water Reservoir

Overhead Tank

Deep Tube Well/Water Pump House

Museum

Historic Sites

Auditorium/ Cinema Hall/ Theater Hall

Brickfield

Kindergarten/Nursery School

Primary School

High School

High School & College

Madrasa

College

NGO School/Other School

University

Refueling Station

Fire Service

Police Box

Police Station

Post Office/Post Box

Power Plant/Electric Sub-Station

Bridge

Culvert

Foot-over Bridge

Rail Gate

Railway Bridge

Railway Over Bridge

Sluice Gate

Structure Type

Katcha/Tin Shed

Semi-pucca

Pucca

Under Construction

Structure Use

Agriculture

Commercial Activities

Education and Research

Government Office

Health Facilities

Industrial Activities

Miscellaneous Use

Mixed Use

Private Office

Recreational Facilities

Religious Facilities

Residential & Homestead

Restricted Area

Warehouse

Transport and Communication

Brickfield

Bus/Truck Terminal

Chatal

Eidgah

Electric Sub-Station/Power Station

Forestland

Katcha Bazaar

Park/Playground/Stadium

Restricted Area

Railway Station

Water Treatment Plant

Waste Disposal Area

Marshland/Beel

Borrow Pits

Lake

Pond

Canal/Irrigation Canal

River

Char

Note: Floor number of Single-storied structures is not labeled

Data Source
RS Mauza Maps, Directorate of Land Records and Survey (DURS), GoB.

Reference Bench Mark (BM)
Horizontal: TPSC-3246 for Latitude/Northing & Longitude/Easting.
Vertical: GPS-5153, BM-7201, BM-6205, BM-701 and BM-702 for Reduce Level (RL) adjustment.

Projection System: Universal Transverse Mercator coordinate system (UTM)
Spheroid : WGS84
Datum : WGS84
Units : Meters
Parameters : 1st standard parallel : 23 09 00 (dd mm ss)
2nd standard parallel : 28 48 00 (dd mm ss)
Central Meridian : 90 00 00 (dd mm ss)
Latitude of projection's origin : 0 00 00 (dd mm ss)
False Easting : 500000 (m)
False Northing : 0.0 (m)

Survey Period : September-December 2015
Date of Field Checking : January 2016
Map Print : January 2016

Development Design Consultants Ltd.

(Md. Nasim Haider) City Specialist Preparation of Action Area Plan for Narayanganj City Corporation	(Dr. Md. Jahurul Hoque) Team Leader Preparation of Action Area Plan for Narayanganj City Corporation
--	---

Local Government Engineering Department (LGED)

(Bivash Das) Urban Planner Preparation of Action Area Plan for Narayanganj and Gazipur City Corporation Project	(Md. Abdus Salam Mandal) Project Director of Long Bridge Construction Project on Upazila and Union Road, LGED & Assigned Officer of Preparation of Action Area Plan for Narayanganj and Gazipur City Corporation Project
--	--

Narayanganj City Corporation

(Planner Md. Moinal Islam) Urban Planner, Narayanganj City Corporation	(Md. Mostafa Kamal Mazumder) Chief Executive Officer, Narayanganj City Corporation
---	---